


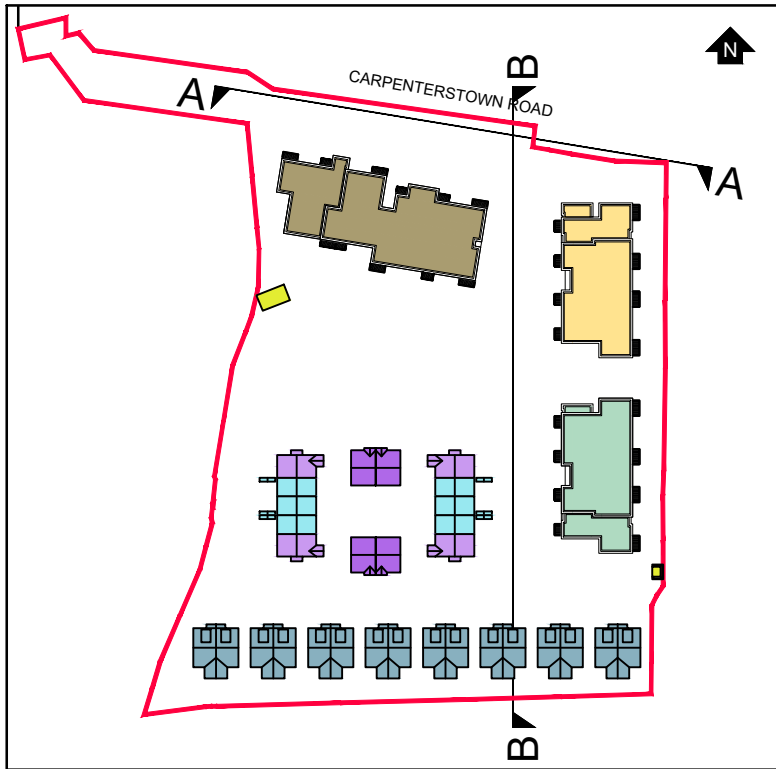


KEY PLAN scale 1:2000



01 Permitted Site Section / Contiguous Elevation AA
1:500 @ A1



 02 Permitted Site Section / Contiguous Elevation AA
1:200 @ A1



Notes:

- Copyright Reserved
- Work to figured dimensions only. Do not scale drawing.
- The contractor is responsible for checking all levels and dimensions on site and shall refer all discrepancies to the Architect
- Where appropriate, for details of f.c. structure, or mechanical and electrical details, see Engineers drawings
- Proprietary items shall be fixed in strict accordance with manufacturers instructions.
- Sizes of proprietary items shall be checked with manufacturer.
- The contractor shall be responsible for the coordination of structure, finishes and services.

Issue Status		
Progress		
Planning Application		
Fire Cert		
Disability Cert		
Tender		
Construction		
As Built		
Information Only		

No.	Date	Revision	Initials
01	30.07.26	Issued for Planning Application	sb

Project	Winterwood Residential Development Castletknock		
Drawing Title	Proposed Contiguous Site Sections & Elevations AA		
Drawing No	6330-PL3-S-E003		
Scale	varies@A1	Rev 01	Drawn sb Date 30/07/26

bkdarchitects
B U R K E - K E N N E D Y - D O Y L E
ONE WASHINGTON BUILDING, WASHINGTON ROAD, DUBLIN 4 D04 X4C
Email: ARCHITECTURE@BKD.IE Phone: 01 616 2400 Web: WWW.BKD.IE