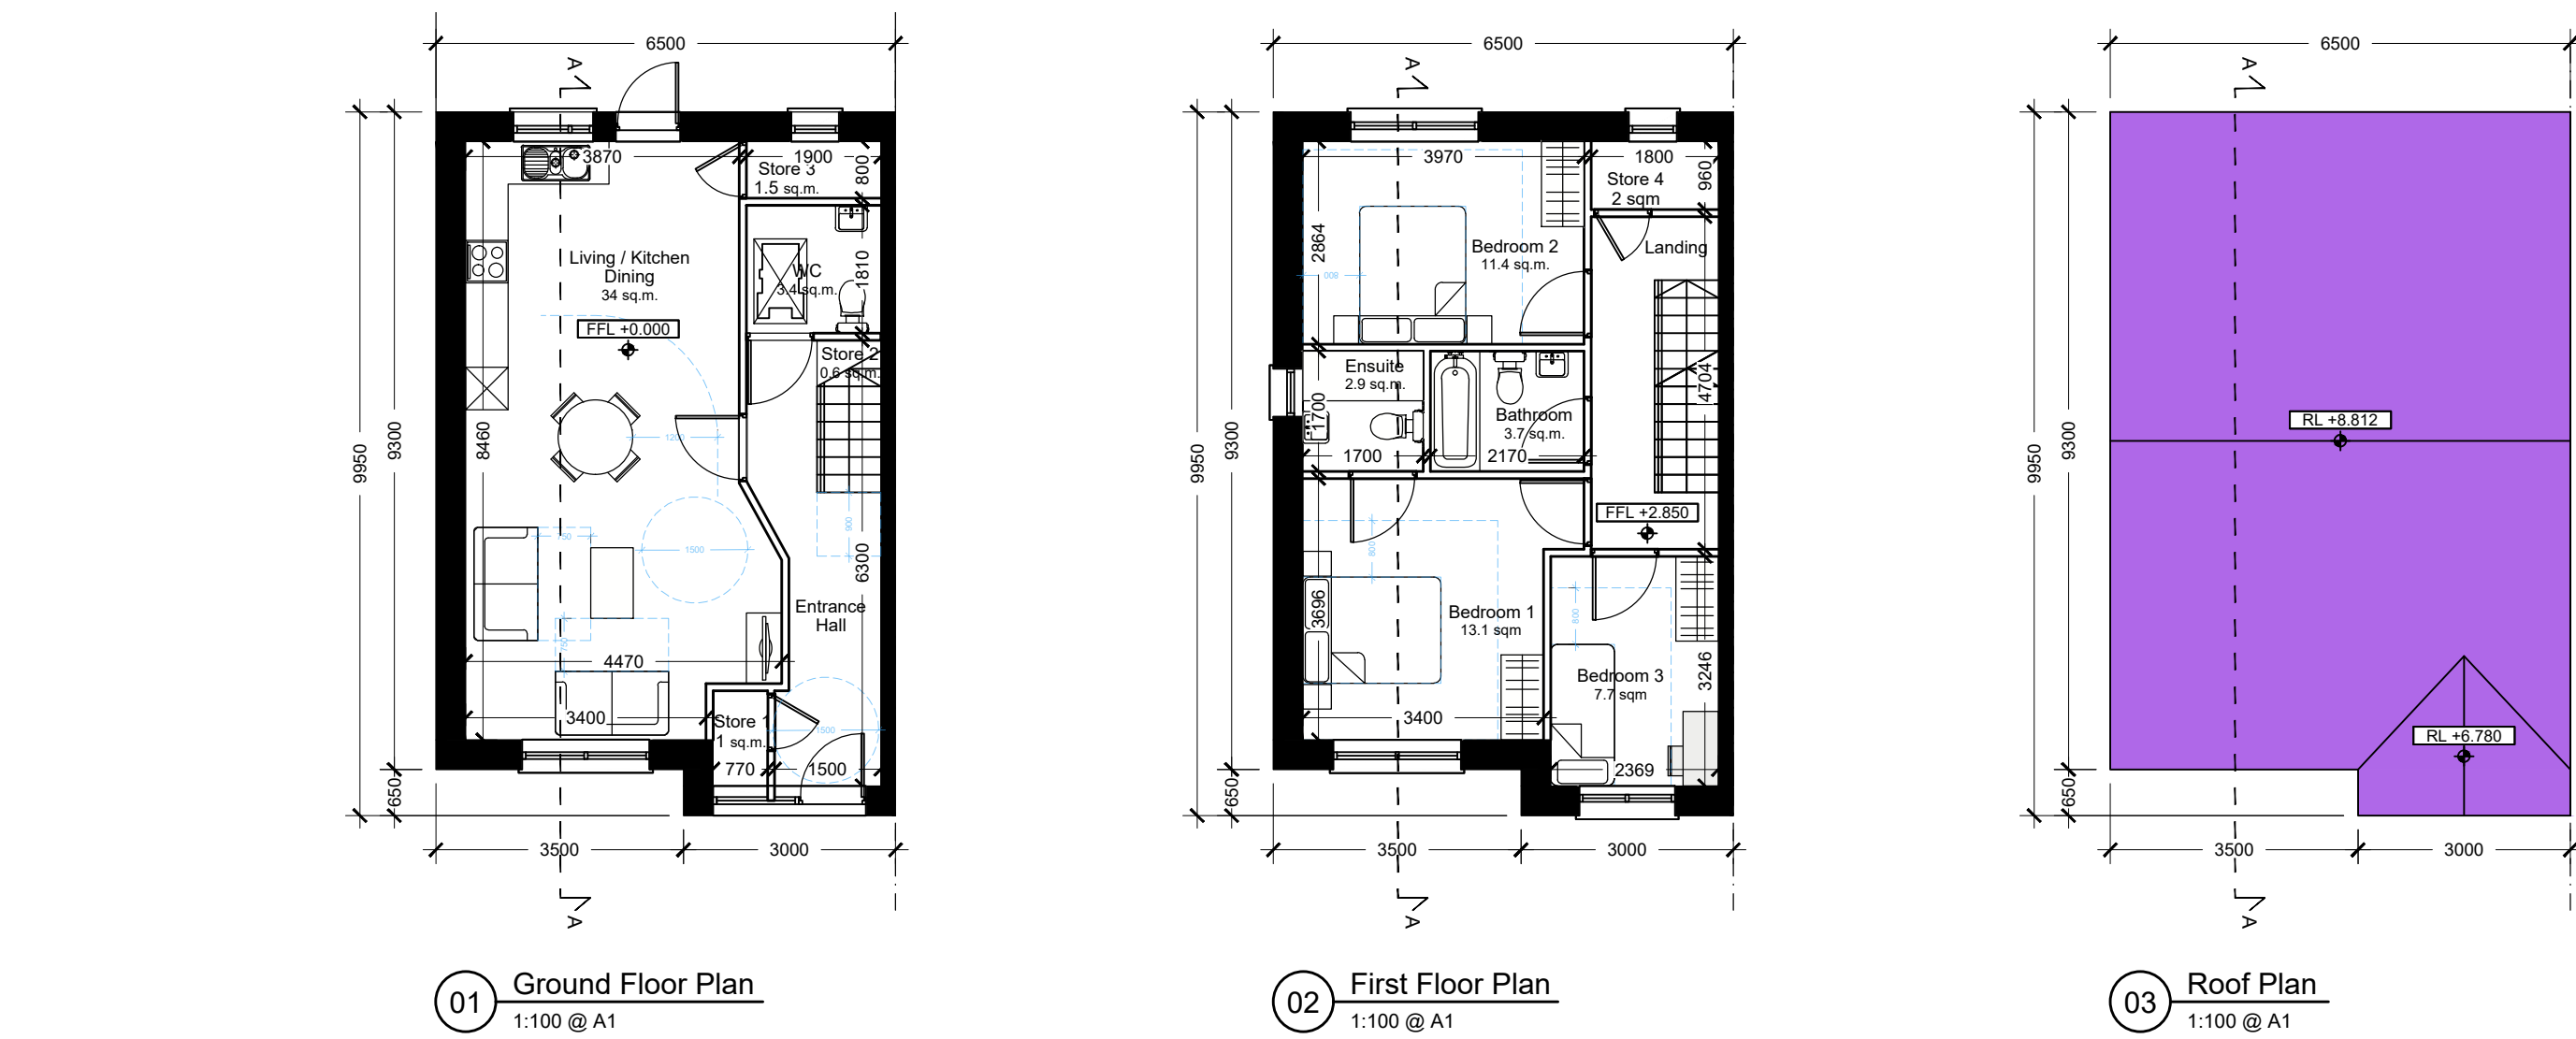
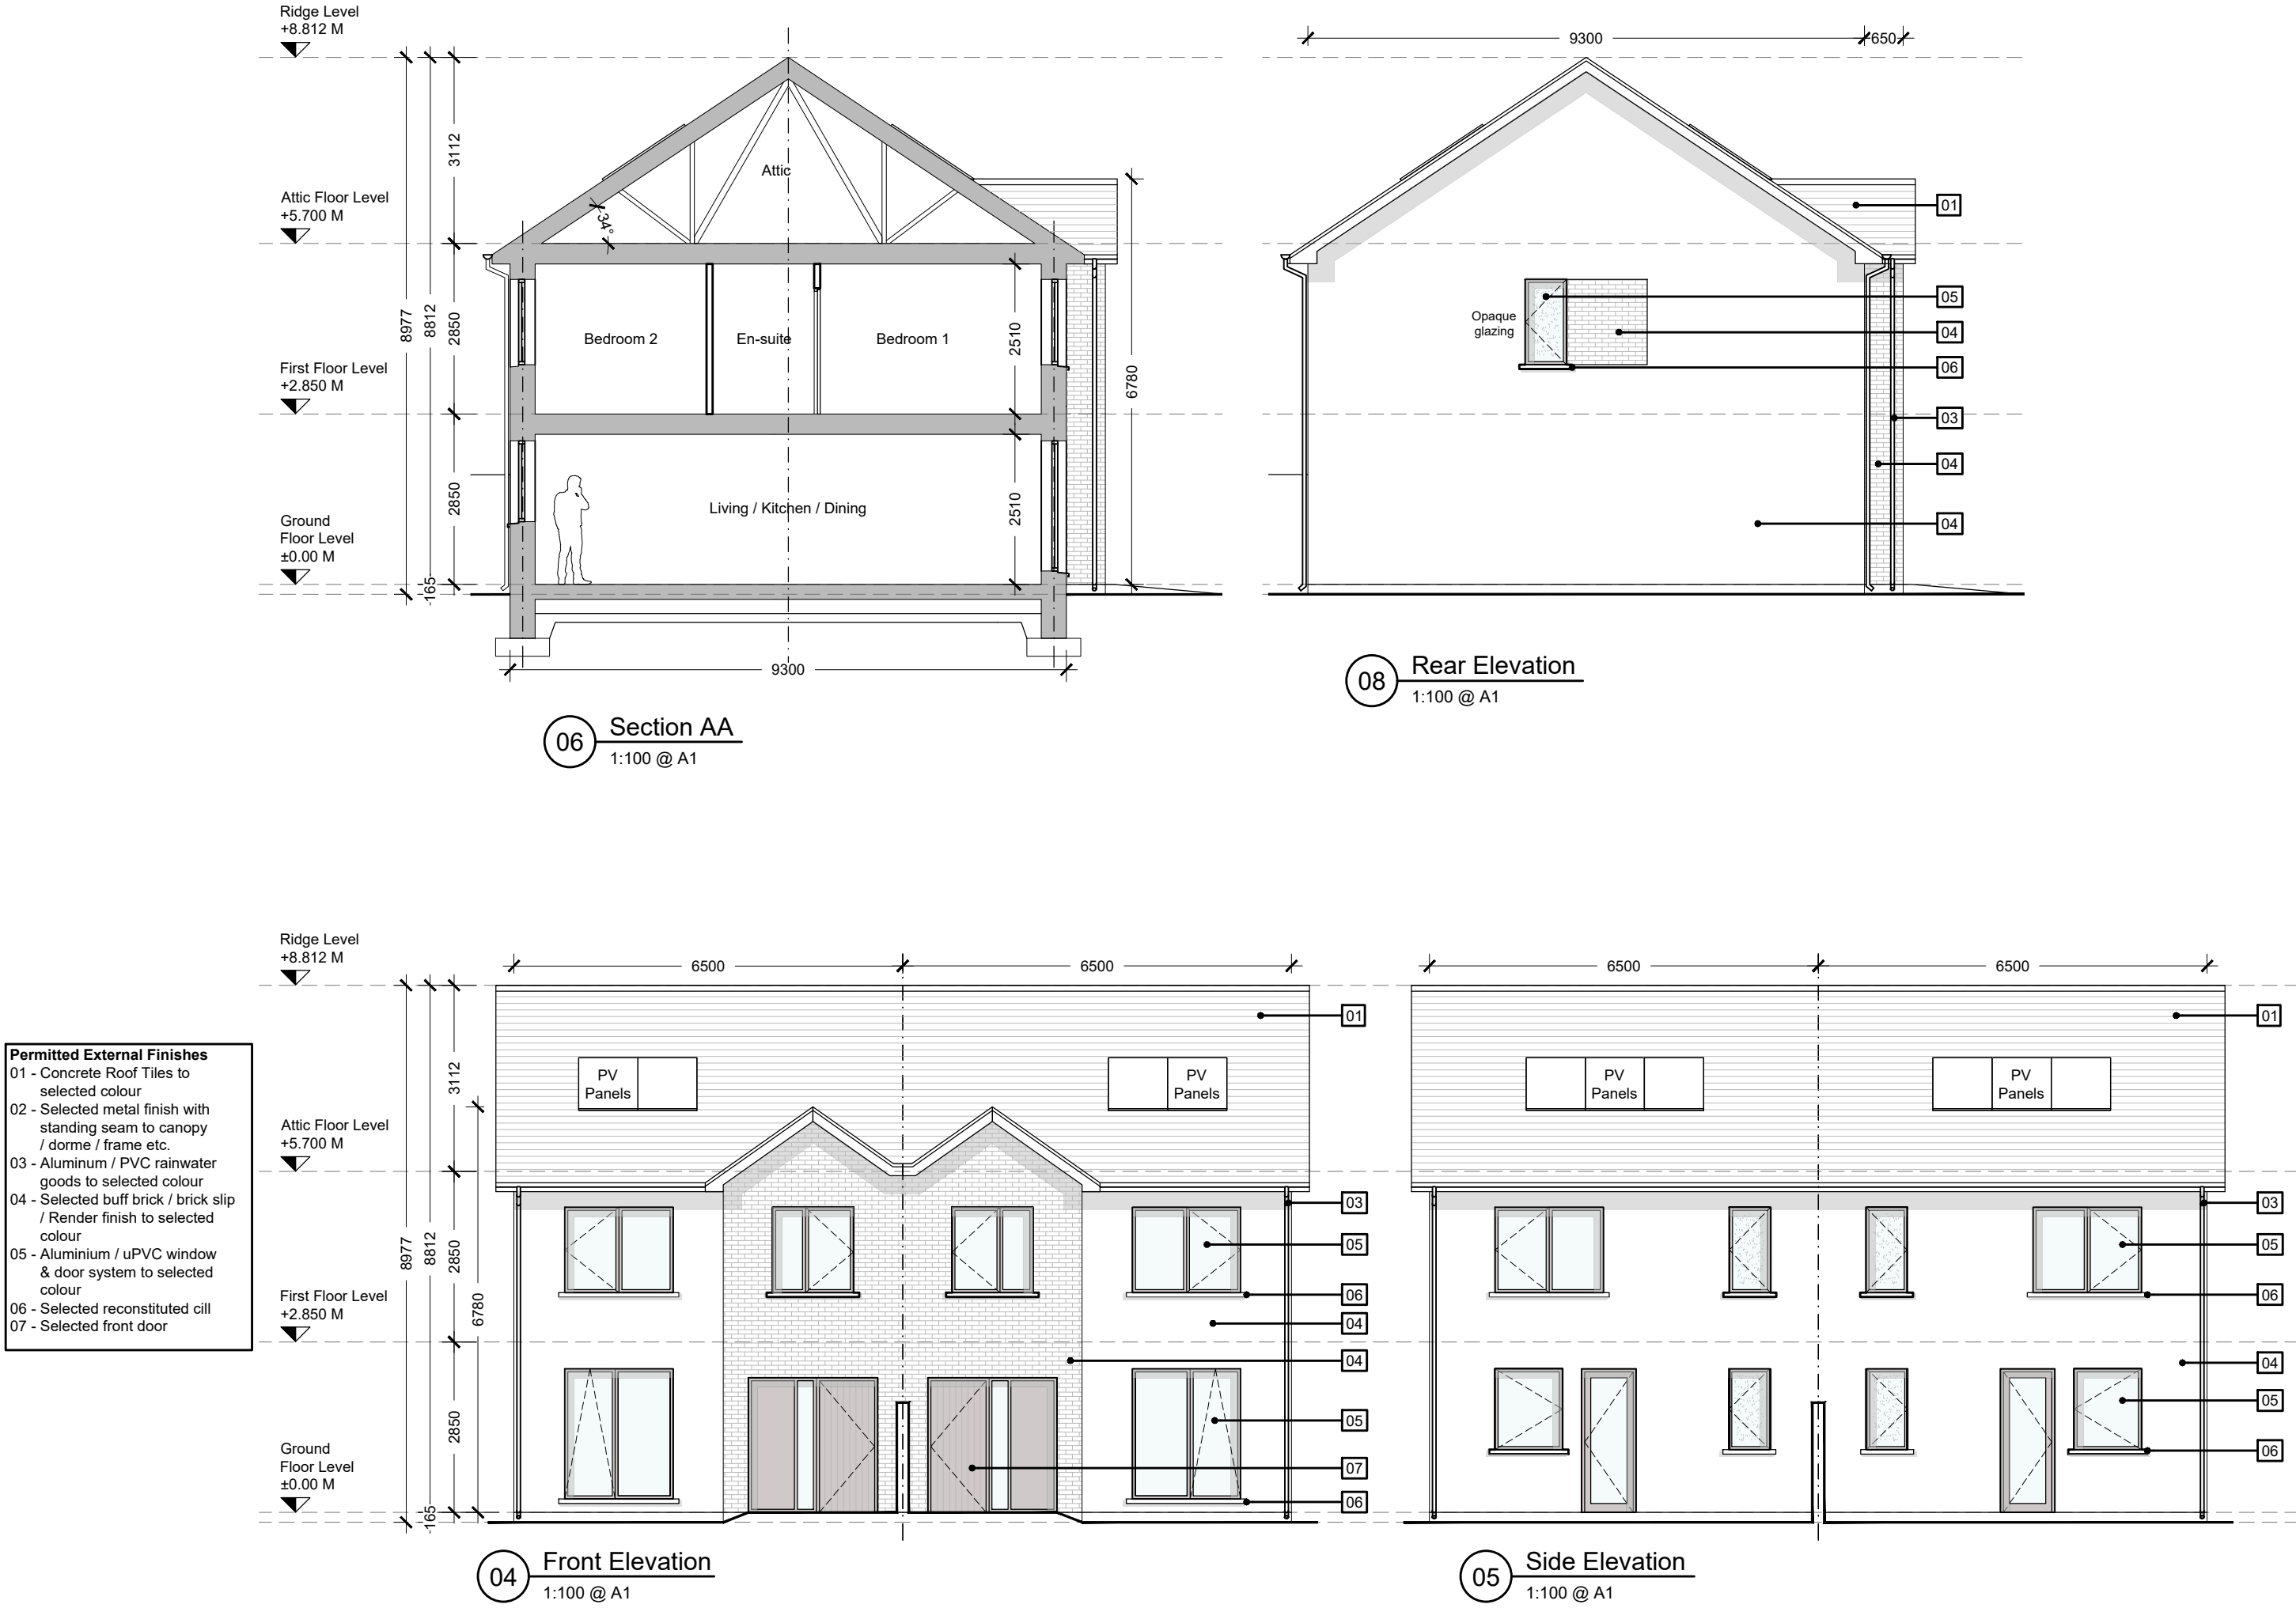


- Notes
- Copyright Reserved
 - Work to figured dimensions only. Do not scale drawing.
 - The contractor is responsible for checking all levels and dimensions on site and shall refer all discrepancies to the Architect
 - Where appropriate, for details of f.c. structure, or mechanical and electrical details, see Engineers drawings
 - Proprietary items shall be fixed in strict accordance with manufacturers instructions.
 - Sizes of proprietary items shall be checked with manufacturer.
 - The contractor shall be responsible for the coordination of structure, finishes and services.

Issue Status

Progress	
Planning Application	
Fire Cert	
Disability Cert	
Tender	
Construction	
As Built	
Information Only	

M:\Project Section - Current\6330 Winterwood\CAD\Planning\House Planning Application\Winterwood - Proposed House Types\HEIGHT STUDY.dwg, 30/07/2026 08:23:52

PERMITTED PLANNING



Additional Floor Area

Type D
4 Bed Semi-Detached

NOTE: REFER TO SITE LAYOUT
PLAN FOR ORIENTATION AND
FINISHED FLOOR LEVELS

PROPOSED PLANNING

Project
**Winterwood Residential Development
Castleknock**

Drawing Title
House Type D - Permitted & Proposed Drawings

Drawing No
6330-PL3-D-P001

Scale 1:100@A1 Rev 02 Drawn sb Date 13/07/26

bkdarchitects
ONE WASHINGTON BUILDING, WASHINGTON ROAD, DUBLIN 4 D04 X403
email: ARCHITECTURE@BKD.IE phone: 01 616 2400 web: WWW.BKD.IE

No.	Date	Revision	Initials
01	03.03.26	Updated following GP comments	sb
02	30.07.26	Ground floor extension reduced by 150mm	sb