

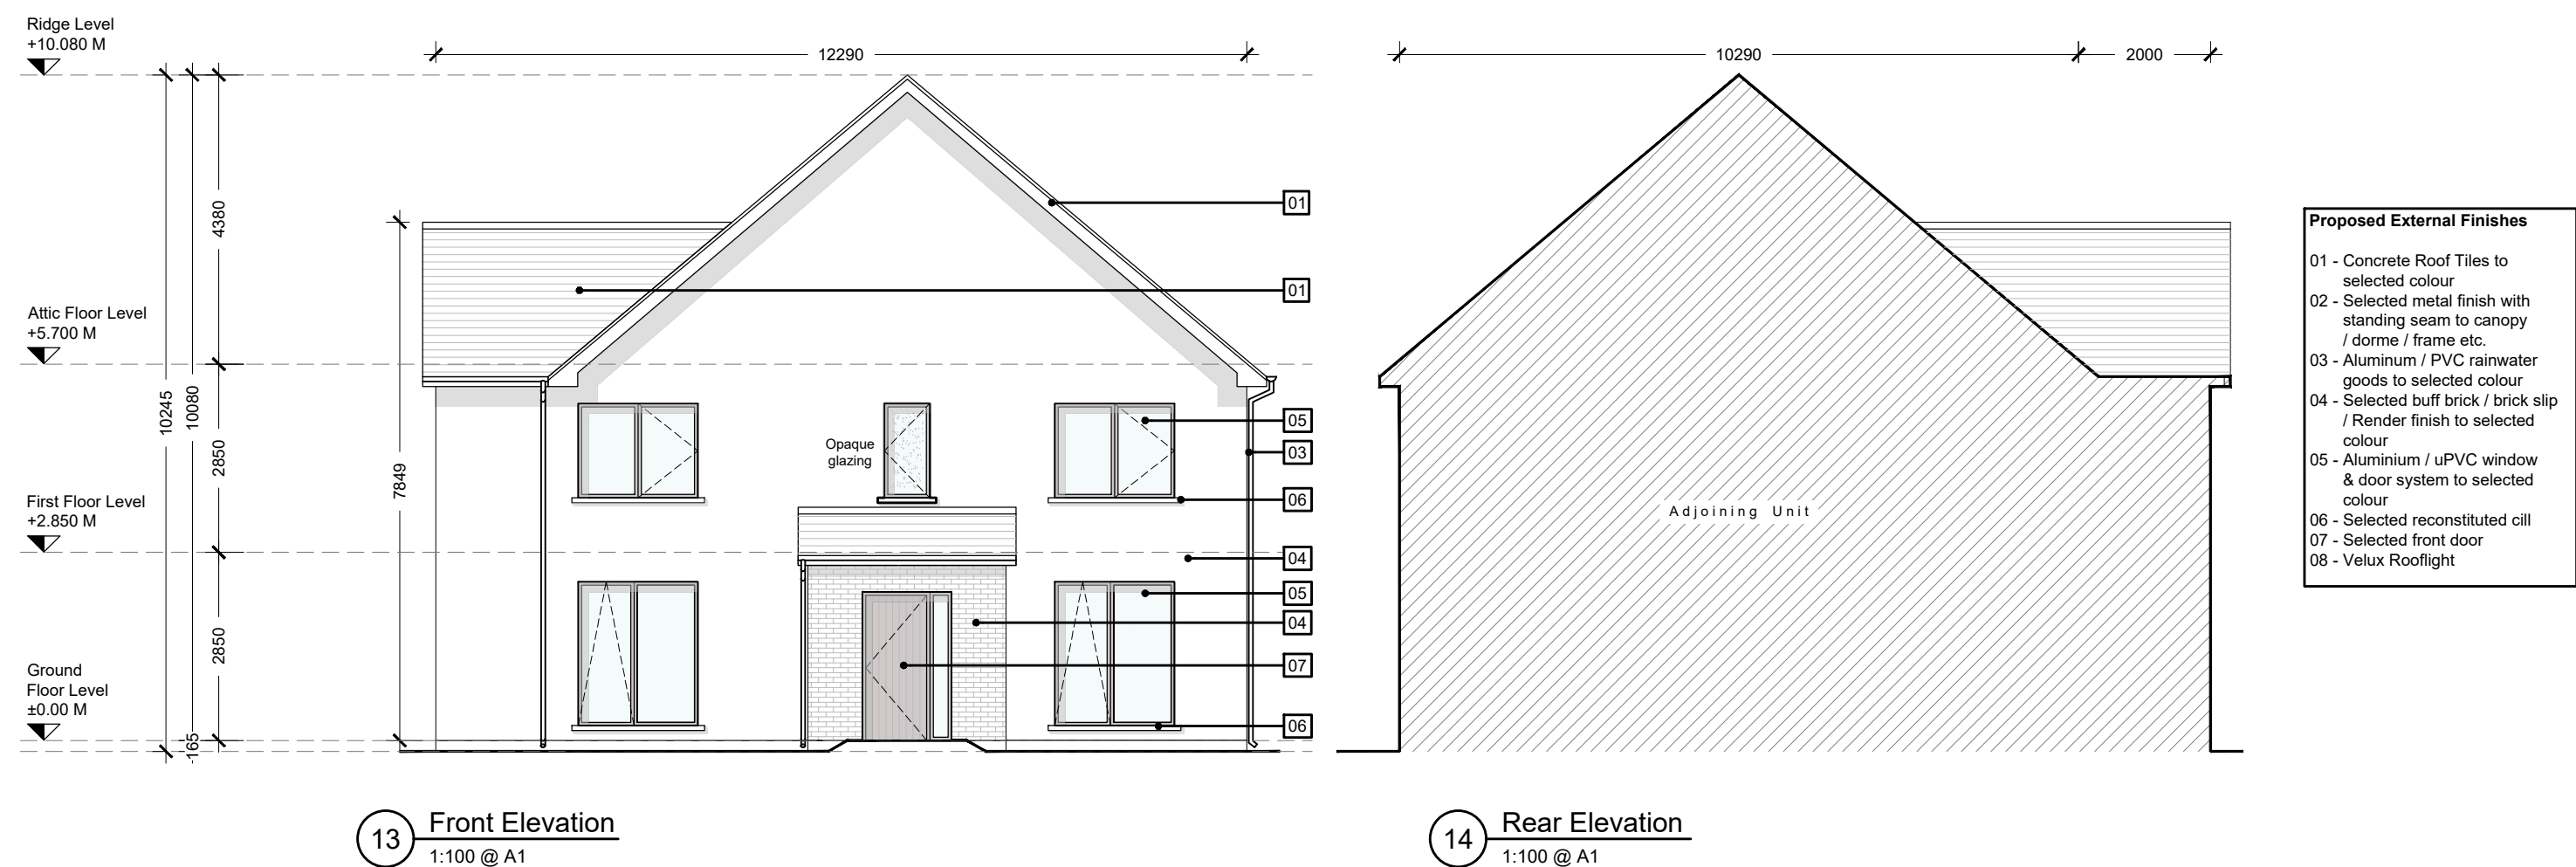
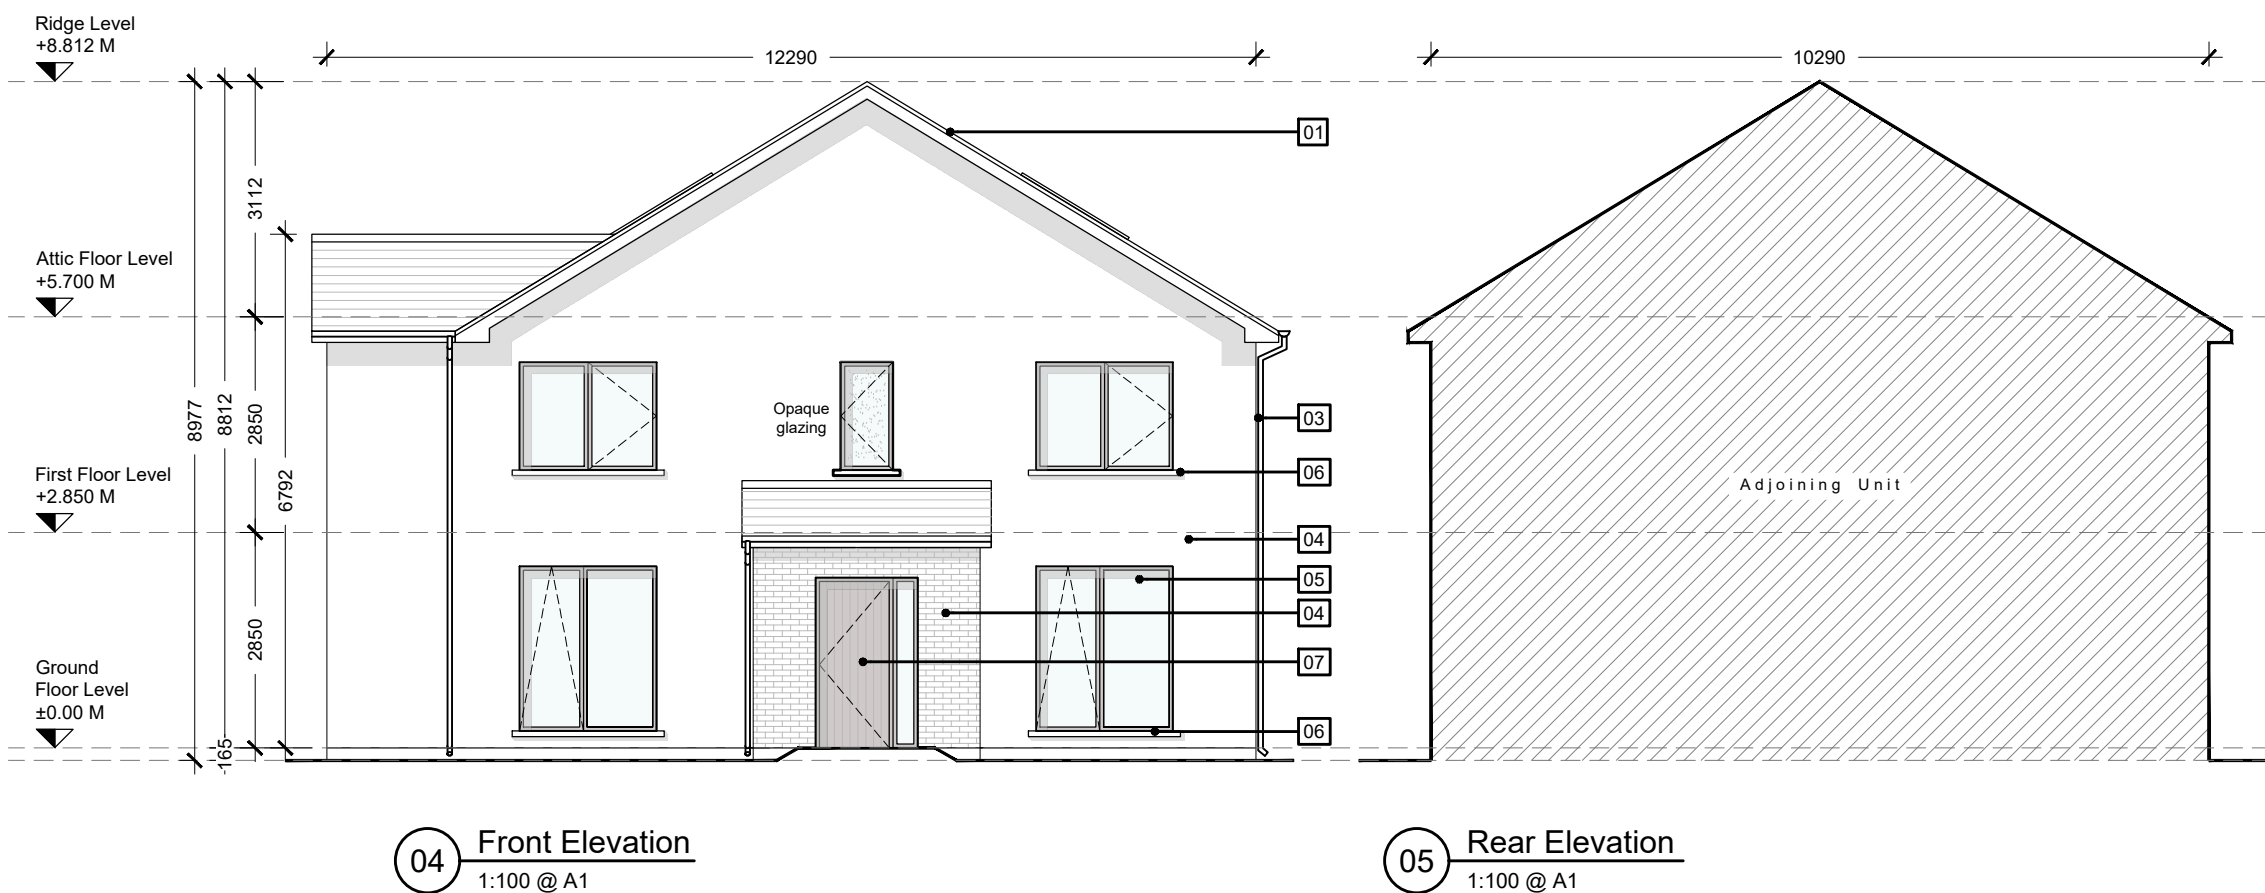
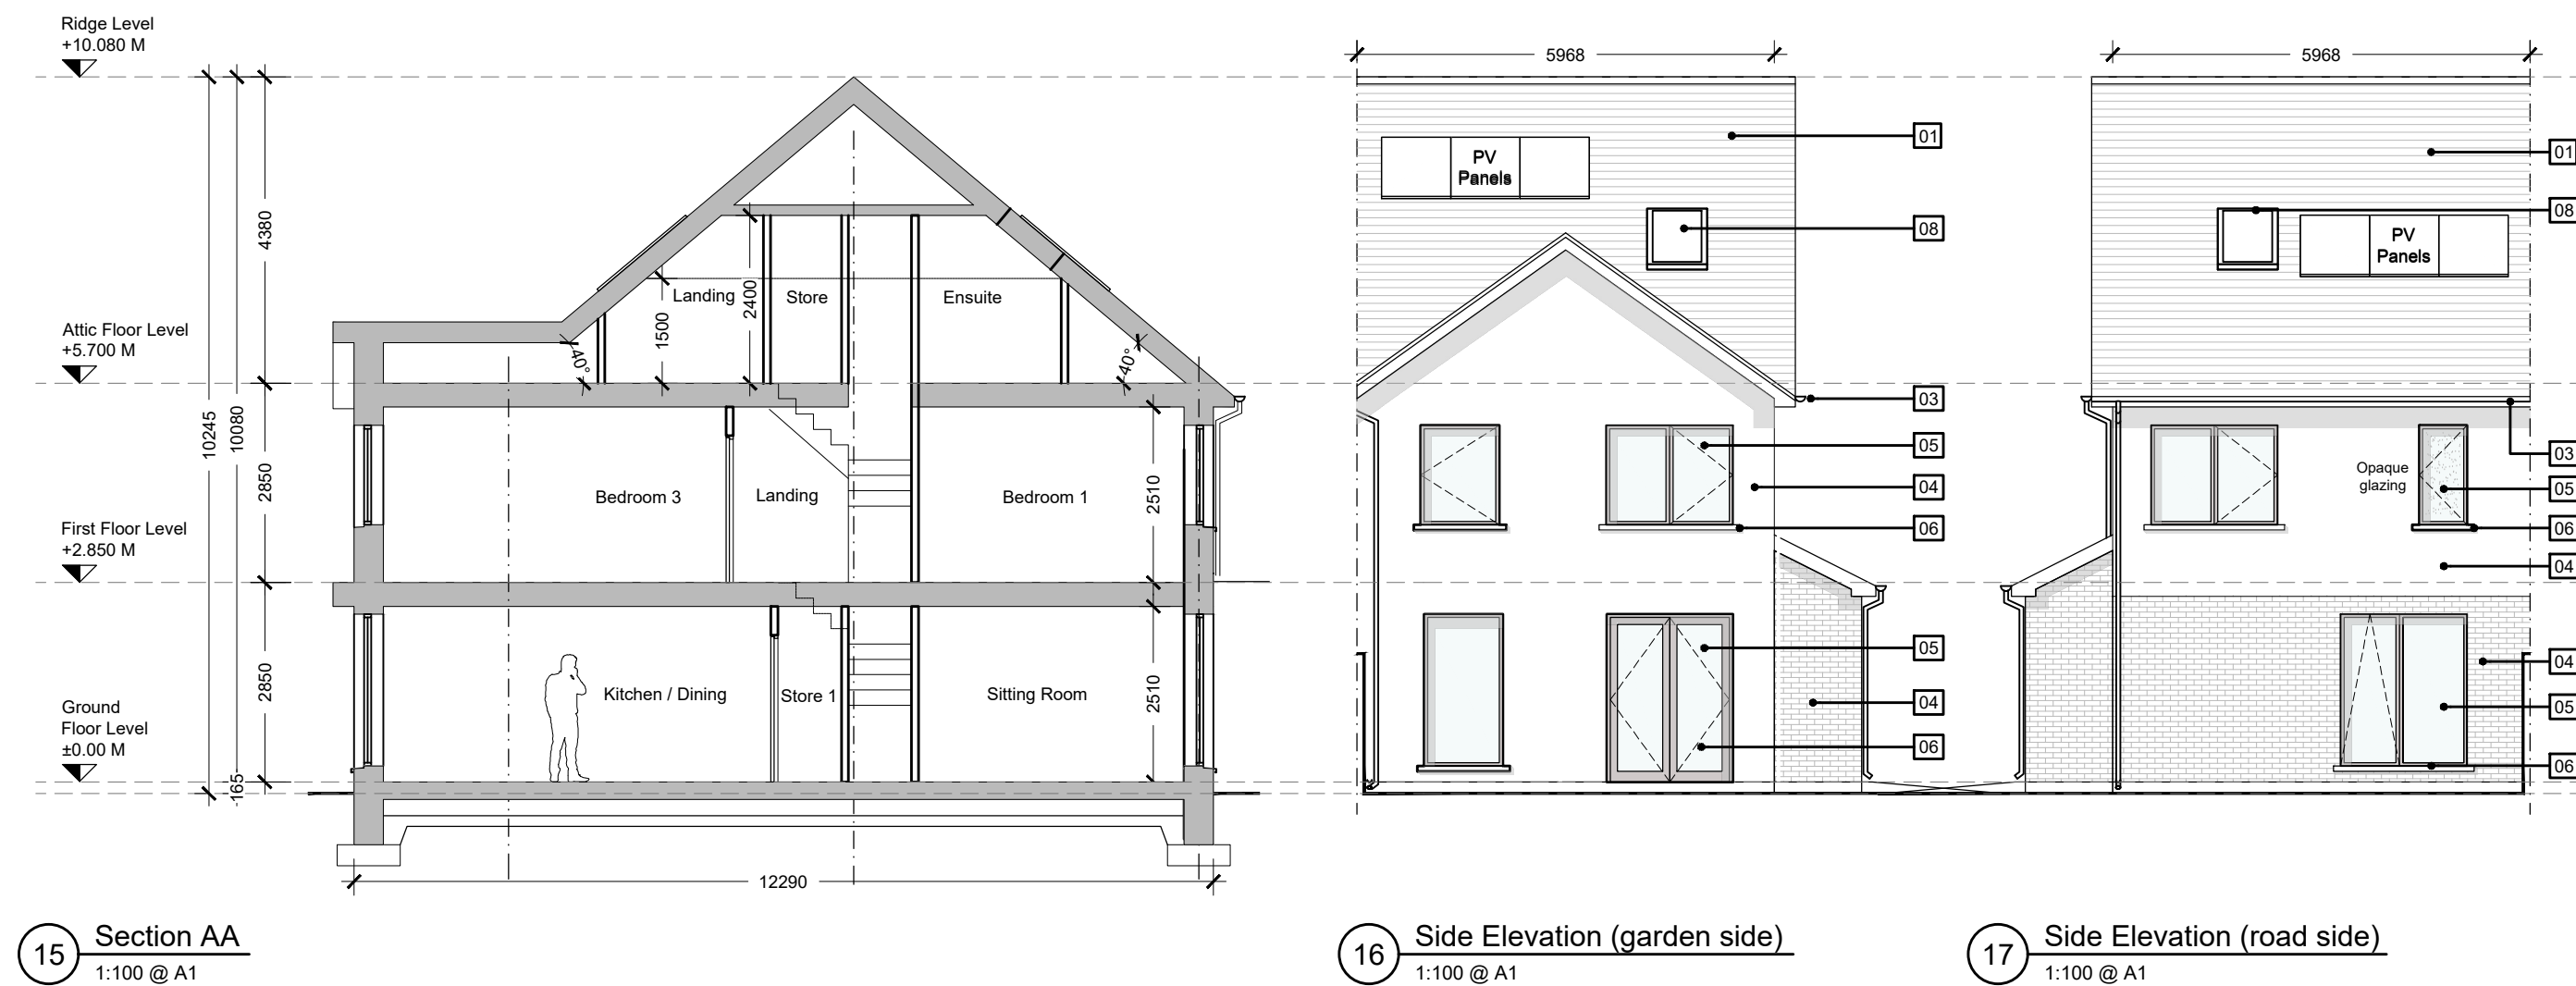
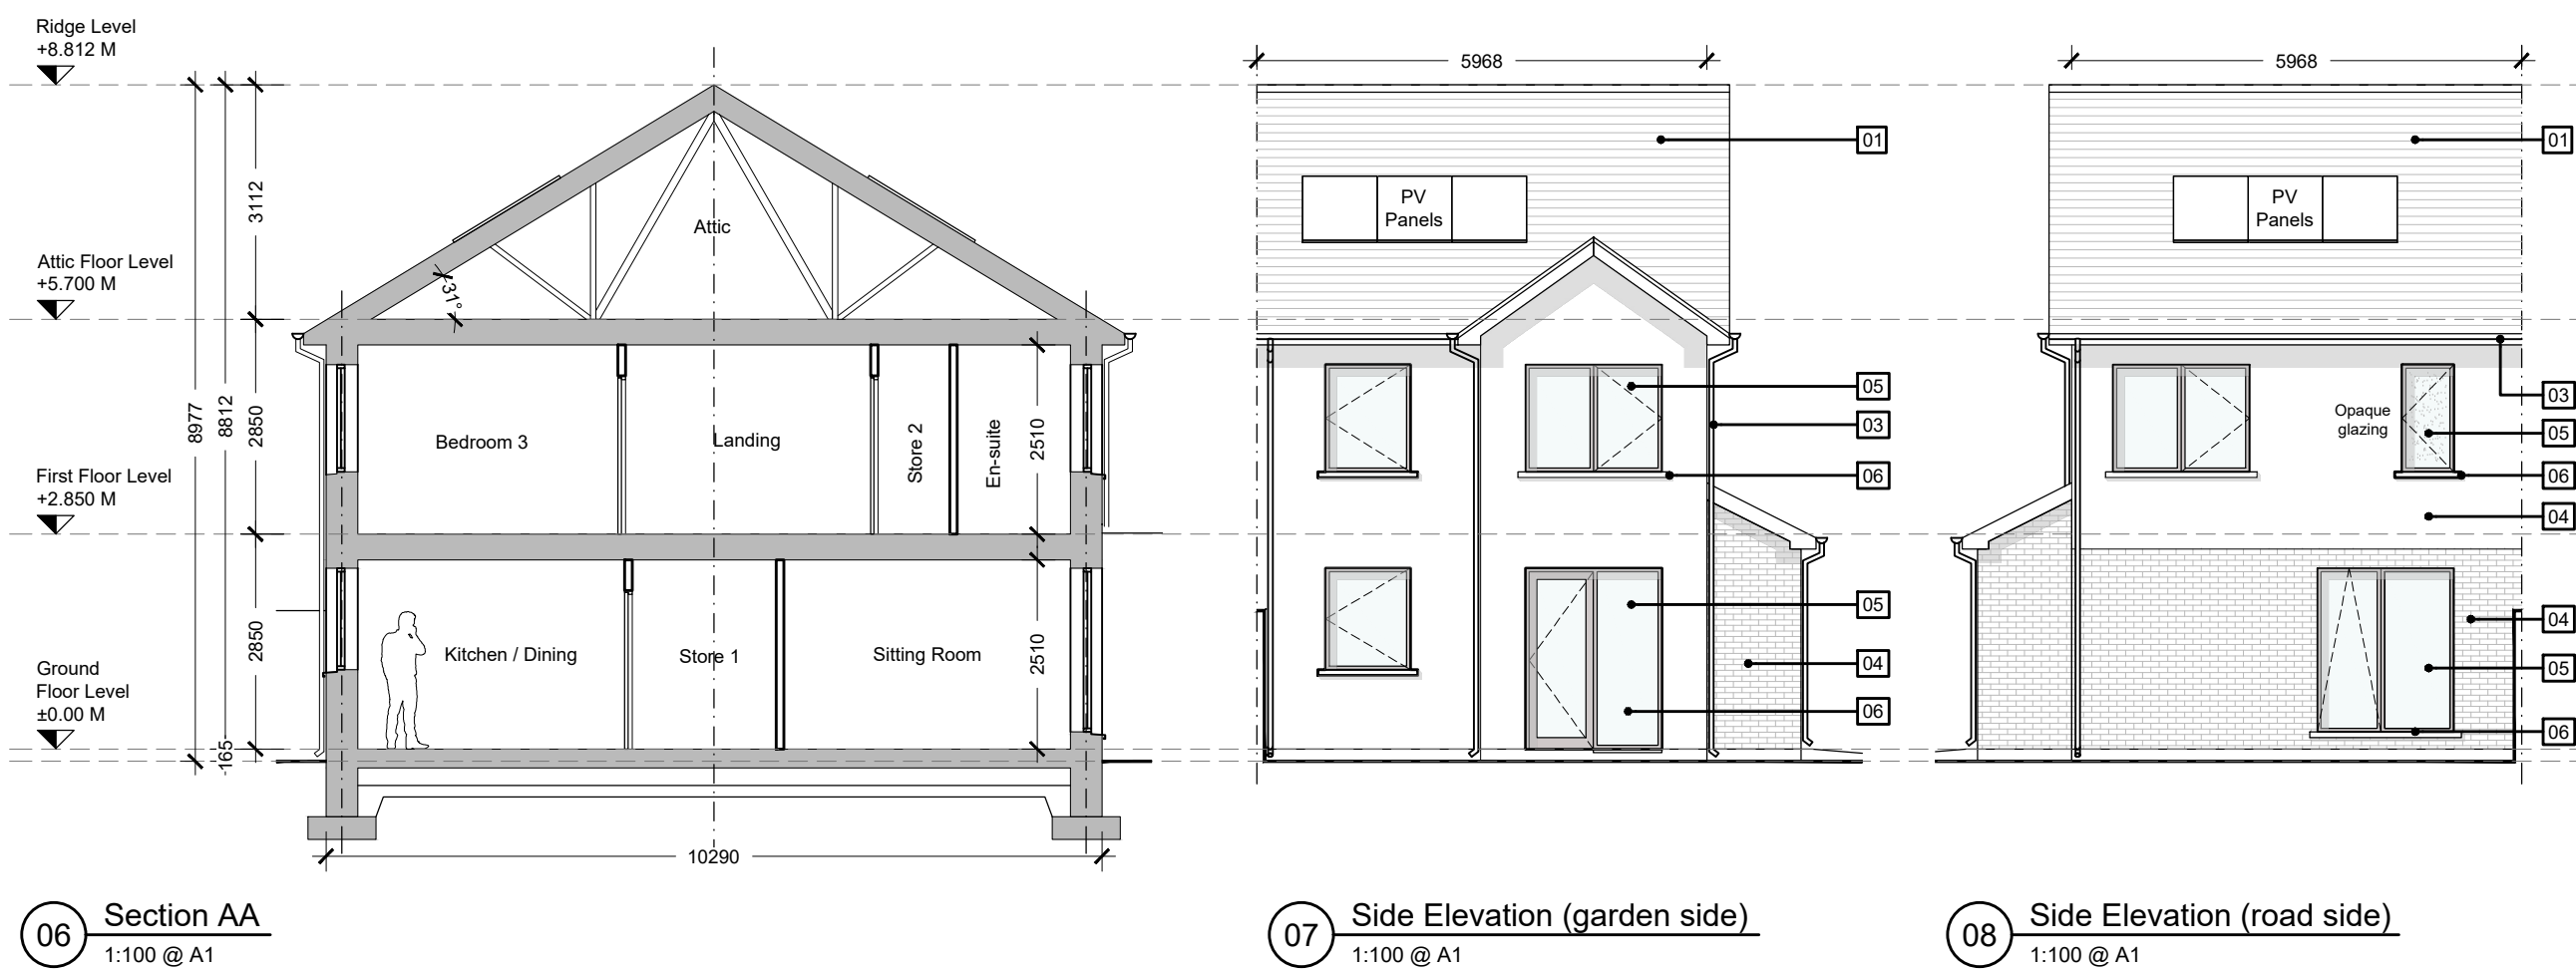


- Permitted External Finishes**
- 01 - Concrete Roof Tiles to selected colour
 - 02 - Selected metal finish with standing seam to canopy / dormer / frame etc.
 - 03 - Aluminium / PVC rainwater goods to selected colour
 - 04 - Selected buff brick / brick slip / render finish to selected colour
 - 05 - Aluminium / uPVC window & door system to selected colour
 - 06 - Selected reconstituted sill
 - 07 - Selected front door

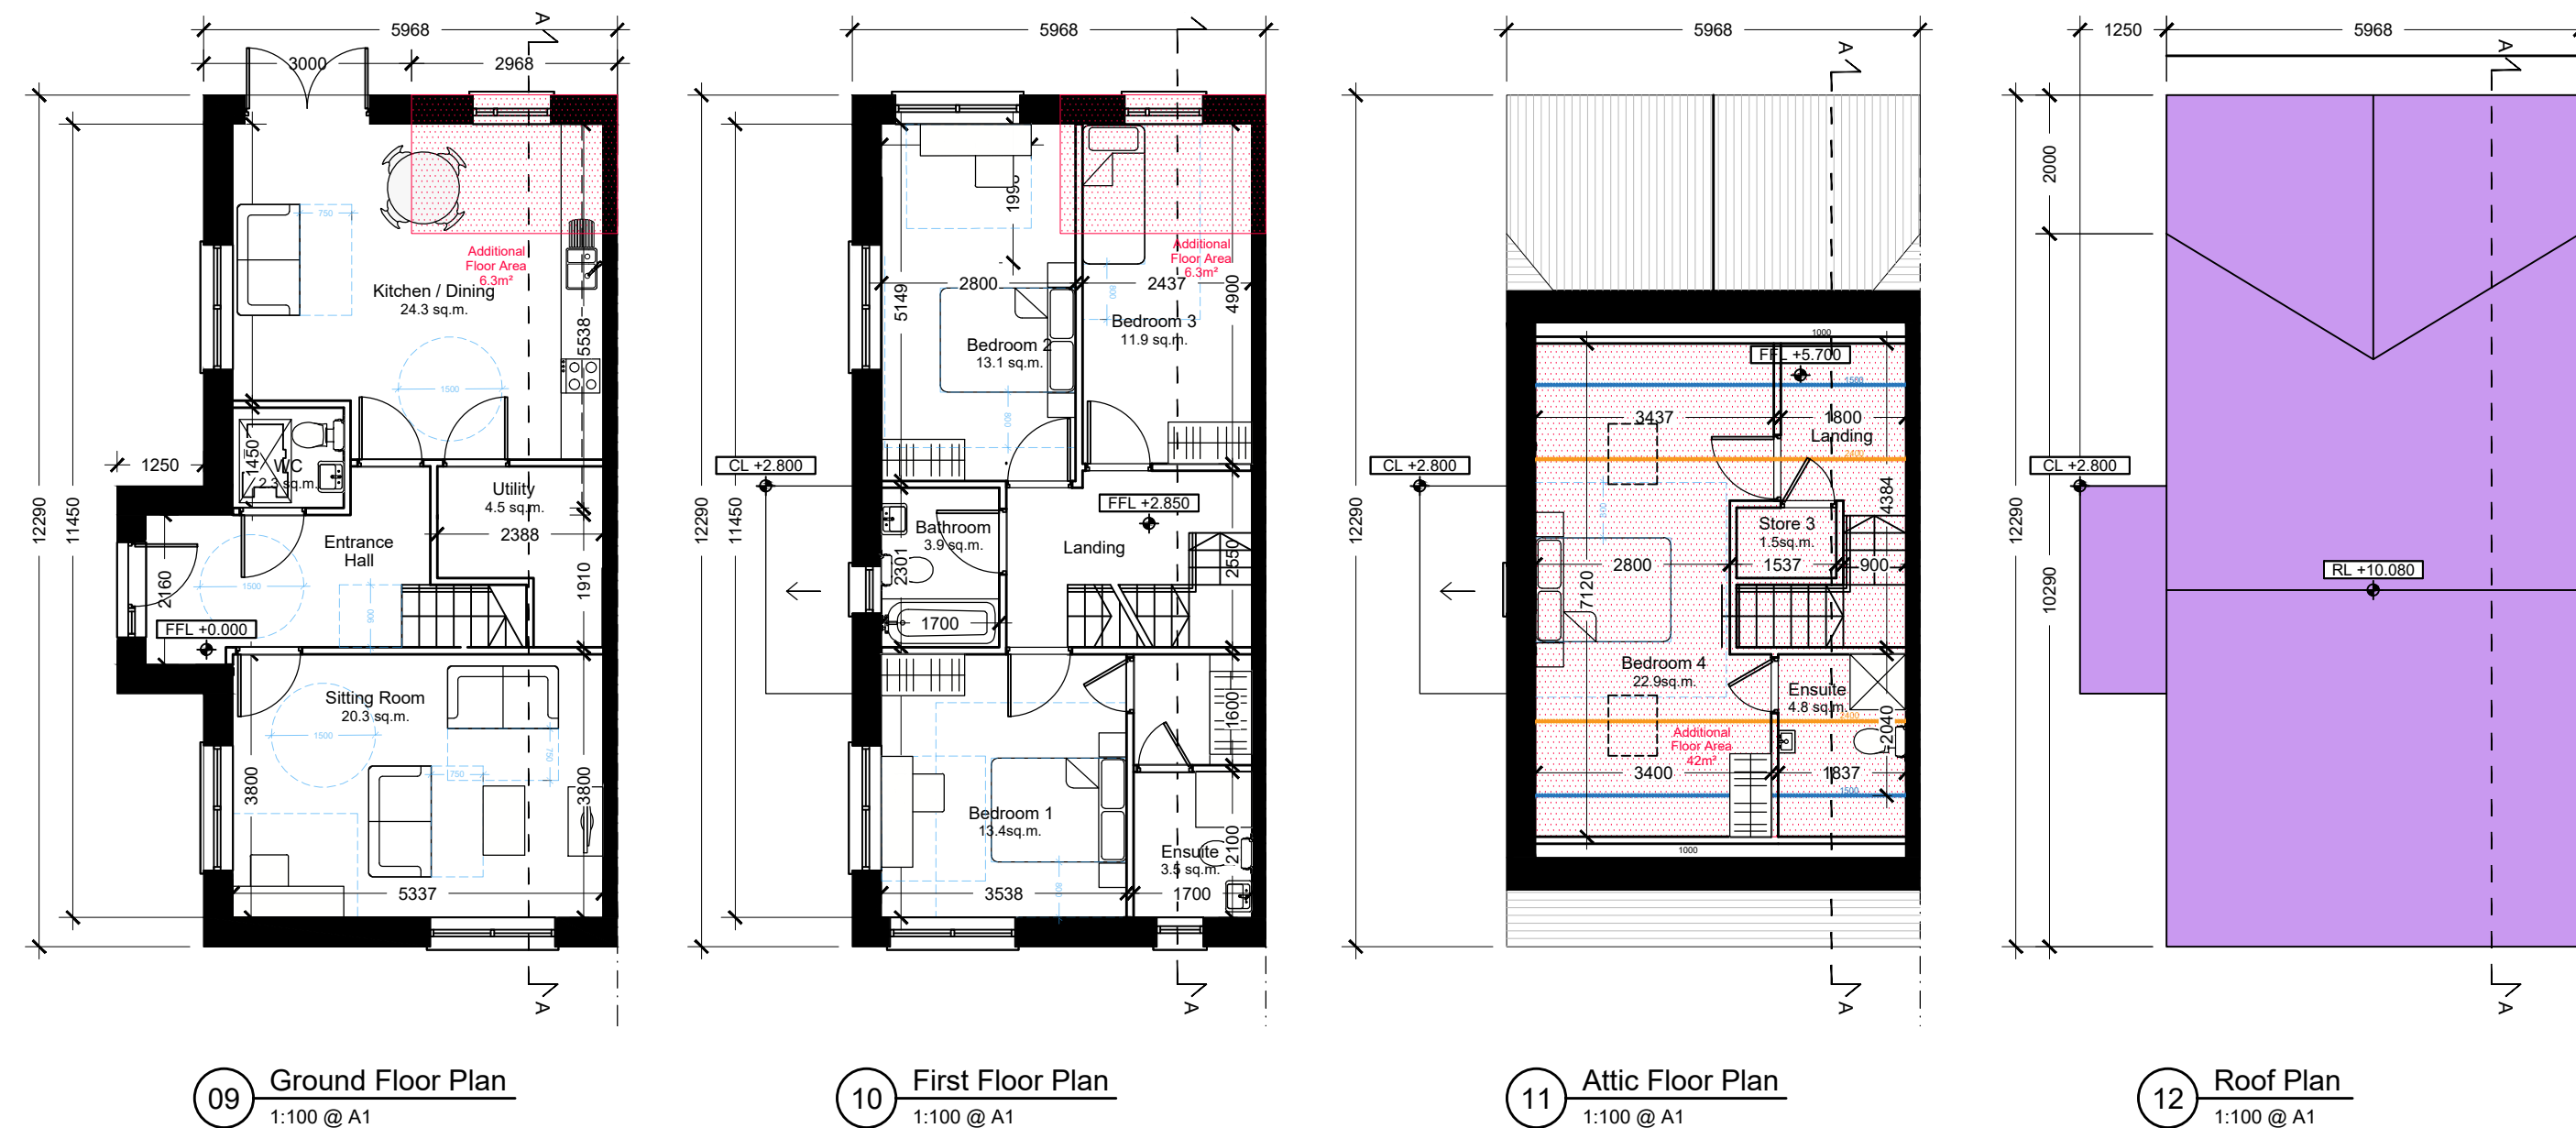

- Proposed External Finishes**
- 01 - Concrete Roof Tiles to selected colour
 - 02 - Selected metal finish with standing seam to canopy / dormer / frame etc.
 - 03 - Aluminium / PVC rainwater goods to selected colour
 - 04 - Selected buff brick / brick slip / render finish to selected colour
 - 05 - Aluminium / uPVC window & door system to selected colour
 - 06 - Selected reconstituted sill
 - 07 - Selected front door
 - 08 - Velux Rooflight

 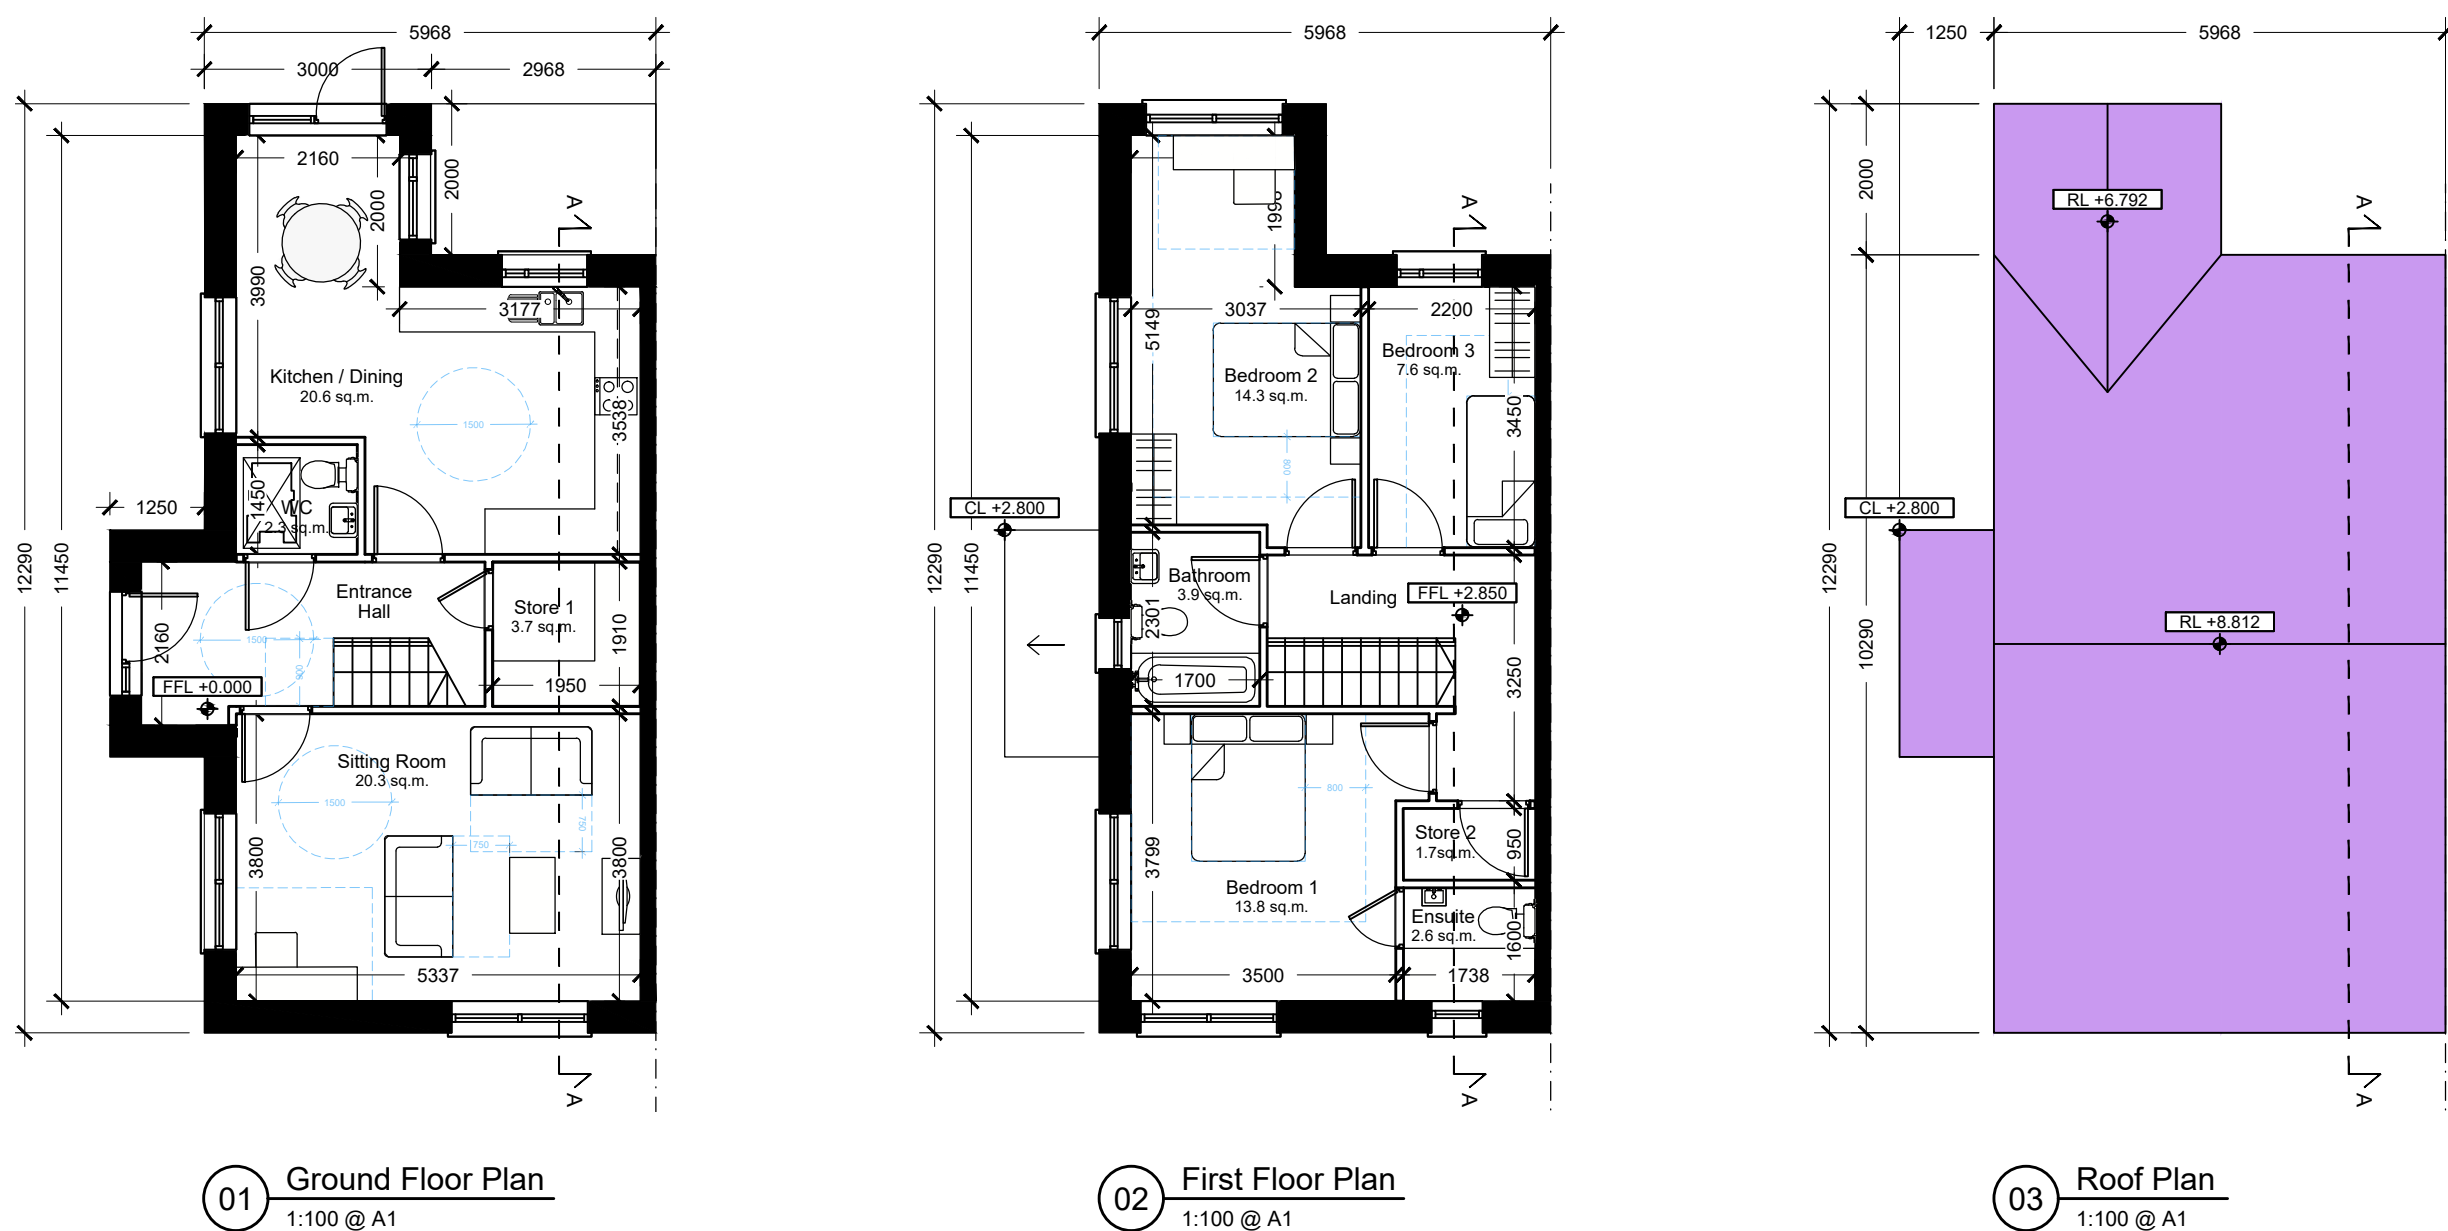


Type C
End terraced
2 storey / 3 bed / 5 person unit
Area: 112.3 sq.m.
GIA ground - 57.5 sqm
GIA first - 54.8 sqm

PERMITTED PLANNING

Type C
End terraced
3 storey / 4 bed / 7 person unit
Area: 161.7 sq.m.
GIA ground - 63.8 sqm
GIA first - 61.1 sqm
GIA second - 36.8 sqm

PROPOSED PLANNING



- Notes**
- Copyright Reserved
 - Work to figured dimensions only. Do not scale drawing.
 - The contractor is responsible for checking all levels and dimensions on site and shall refer all discrepancies to the Architect
 - Where appropriate, for details of i.e. structure, or mechanical and electrical details, see Engineers drawings
 - Proprietary items shall be fixed in strict accordance with manufacturers instructions.
 - Sizes of proprietary items shall be checked with manufacturer.
 - The contractor shall be responsible for the coordination of structure, finishes and services.

Issue Status	
Progress	
Planning Application	
Fire Cert	
Disability Cert	
Tender	
Construction	
As Built	
Information Only	

No.	Date	Revision	Initials
01	13.07.26	Issued for Planning Application	sb

Project	Winterwood Residential Development Castleknock
Drawing Title	House Type C - Permitted & Proposed Drawings
Drawing No	6330-PL3-C-P001
Scale	1:100@A1
Rev	01
Drawn	sb
Date	13/07/26

bkdarchitects
B R U K E - K E N N E D Y - D O Y L E
ONE WASHINGTON BUILDING, WASHINGTON ROAD, DUBLIN 4 D04 X401
email: ARCHITECTURE@BKD.ie phone: 01 616 2400 web: WWW.BKD.IE