


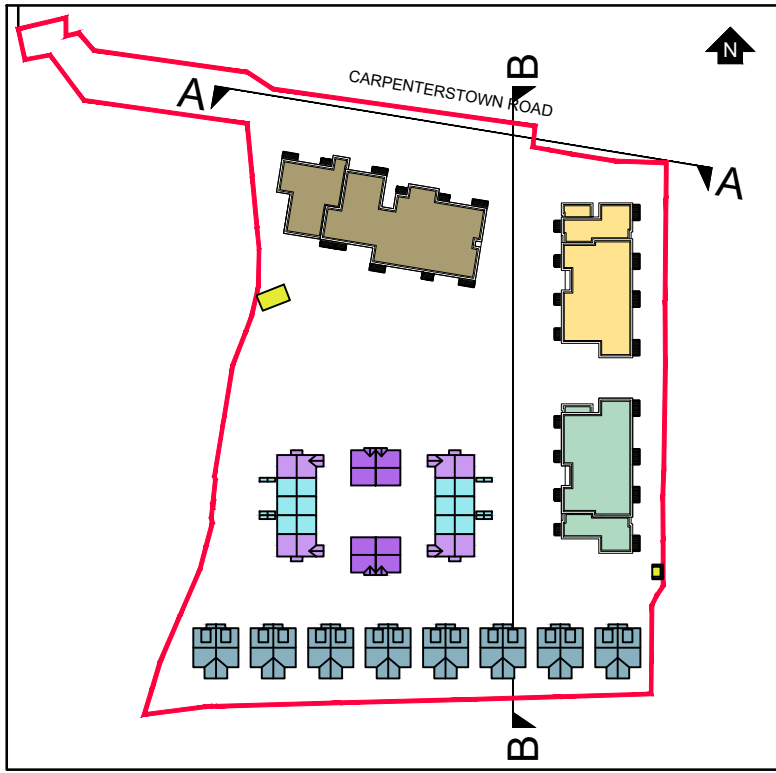


KEY PLAN scale 1:2000



01 Permitted Site Section / Contiguous Elevation AA
1:500 @ A1



 02 Permitted Site Section / Contiguous Elevation AA
1:200 @ A1



Notes
Copyright Reserved
Work to figured dimensions only. Do not scale drawing.
The contractor is responsible for checking all levels and dimensions on site and shall refer all discrepancies to the Architect
Where appropriate, for details of i.e. structure, or mechanical and electrical details, see Engineers drawings
Proprietary items shall be fixed in strict accordance with manufacturers instructions.
Sizes of proprietary items shall be checked with manufacturer.
The contractor shall be responsible for the coordination of structure, finishes and services.

Issue Status
Progress
Planning Application
Fire Cert
Disability Cert
Tender
Construction
As Built
Information Only

No.	Date	Revision	Initials
01	30.07.26	Issued for Planning Application	sb

Project	Winterwood Residential Development Castleknock
Drawing Title	Permitted Contiguous Site Sections & Elevations AA
Drawing No	6330-PL3-S-E001
Scale	varies@A1
Rev	01
Drawn	sb
Date	30/07/26